




PROJECT


PUBLIC HEALTH
DURHAM COUNTY NC
DURHAM COUNTY
HUMAN SERVICES
COMPLEX

414 E MAIN ST, DURHAM
NC 27701

KEYPLAN

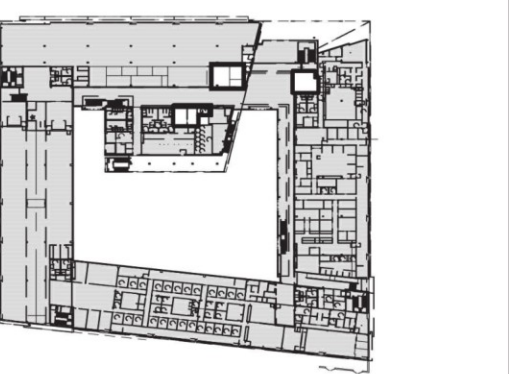

LEVEL 01

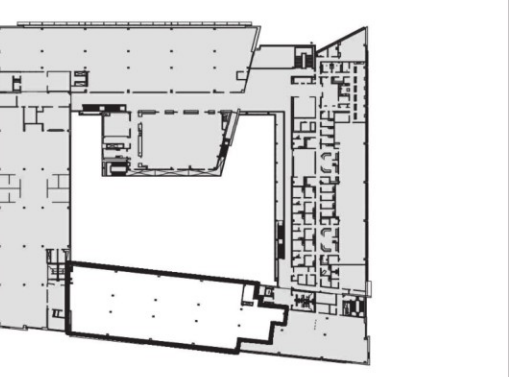

LEVEL 02

ISSUE CHART

NO.	ISSUE FOR BID	DATE
1	ISSUE FOR BID	2019.11.12
2	ISSUE	2019.11.12

Job Number 830537 000

TITLE
FURNITURE & POWER
PLAN FOR
REFERENCE ONLY -
LEVEL 02
SHEET NUMBER

A15-02

FURNITURE PLAN
GENERAL NOTES

- FURNITURE AND POWER SHOWN FOR REFERENCE AND COORDINATION PURPOSES ONLY.
- COOPERATE FULLY WITH SEPARATE CONTRACTORS SO WORK ON THOSE CONTRACTS MAY BE CARRIED OUT SMOOTHLY, WITHOUT INTERFERING WITH OR DELAYING WORK UNDER THIS CONTRACT OR OTHER CONTRACTS. COORDINATE THE WORK OF THIS CONTRACT WITH WORK PERFORMED UNDER SEPARATE CONTRACTS.
 - CONTRACTOR TO DOCUMENT LAYOUT OF RAISED FLOOR GRID AND ESTABLISH ORIGIN POINT OFF OF NEAREST STRUCTURAL COLUMN GRID.
 - UNDERFLOOR AIR DISTRIBUTION, GRILLES, DIFFUSERS AND ELECTRICAL FLOOR BOX LOCATIONS AND ORIENTATION ARE TO BE COORDINATED WITH SYSTEMS FURNITURE AND DEMOUNTABLE PARTITIONS CONTRACTOR PRIOR TO SETTING FINAL LOCATIONS.

FURNITURE PLAN LEGEND




FIRE PROTECTION LEGEND

- 1-HR FIRE BARRIER
- 2-HR FIRE BARRIER
- 2-HR FIRE WALL
- FIRE EXTINGUISHER CABINET
- EXISTING EXIT LIGHT TO REMAIN
- PATH OF TRAVEL

NOTE: CONSTRUCTION TO BE COMPLETED IN TWO PHASES. PHASE ONE TO BE LEVEL 02 SCOPE. PHASE TWO TO BE LEVEL 01 SCOPE.

FURNITURE PLAN
NOTES BY NUMBER

<<< Indicates Sheet Keynote on Plan

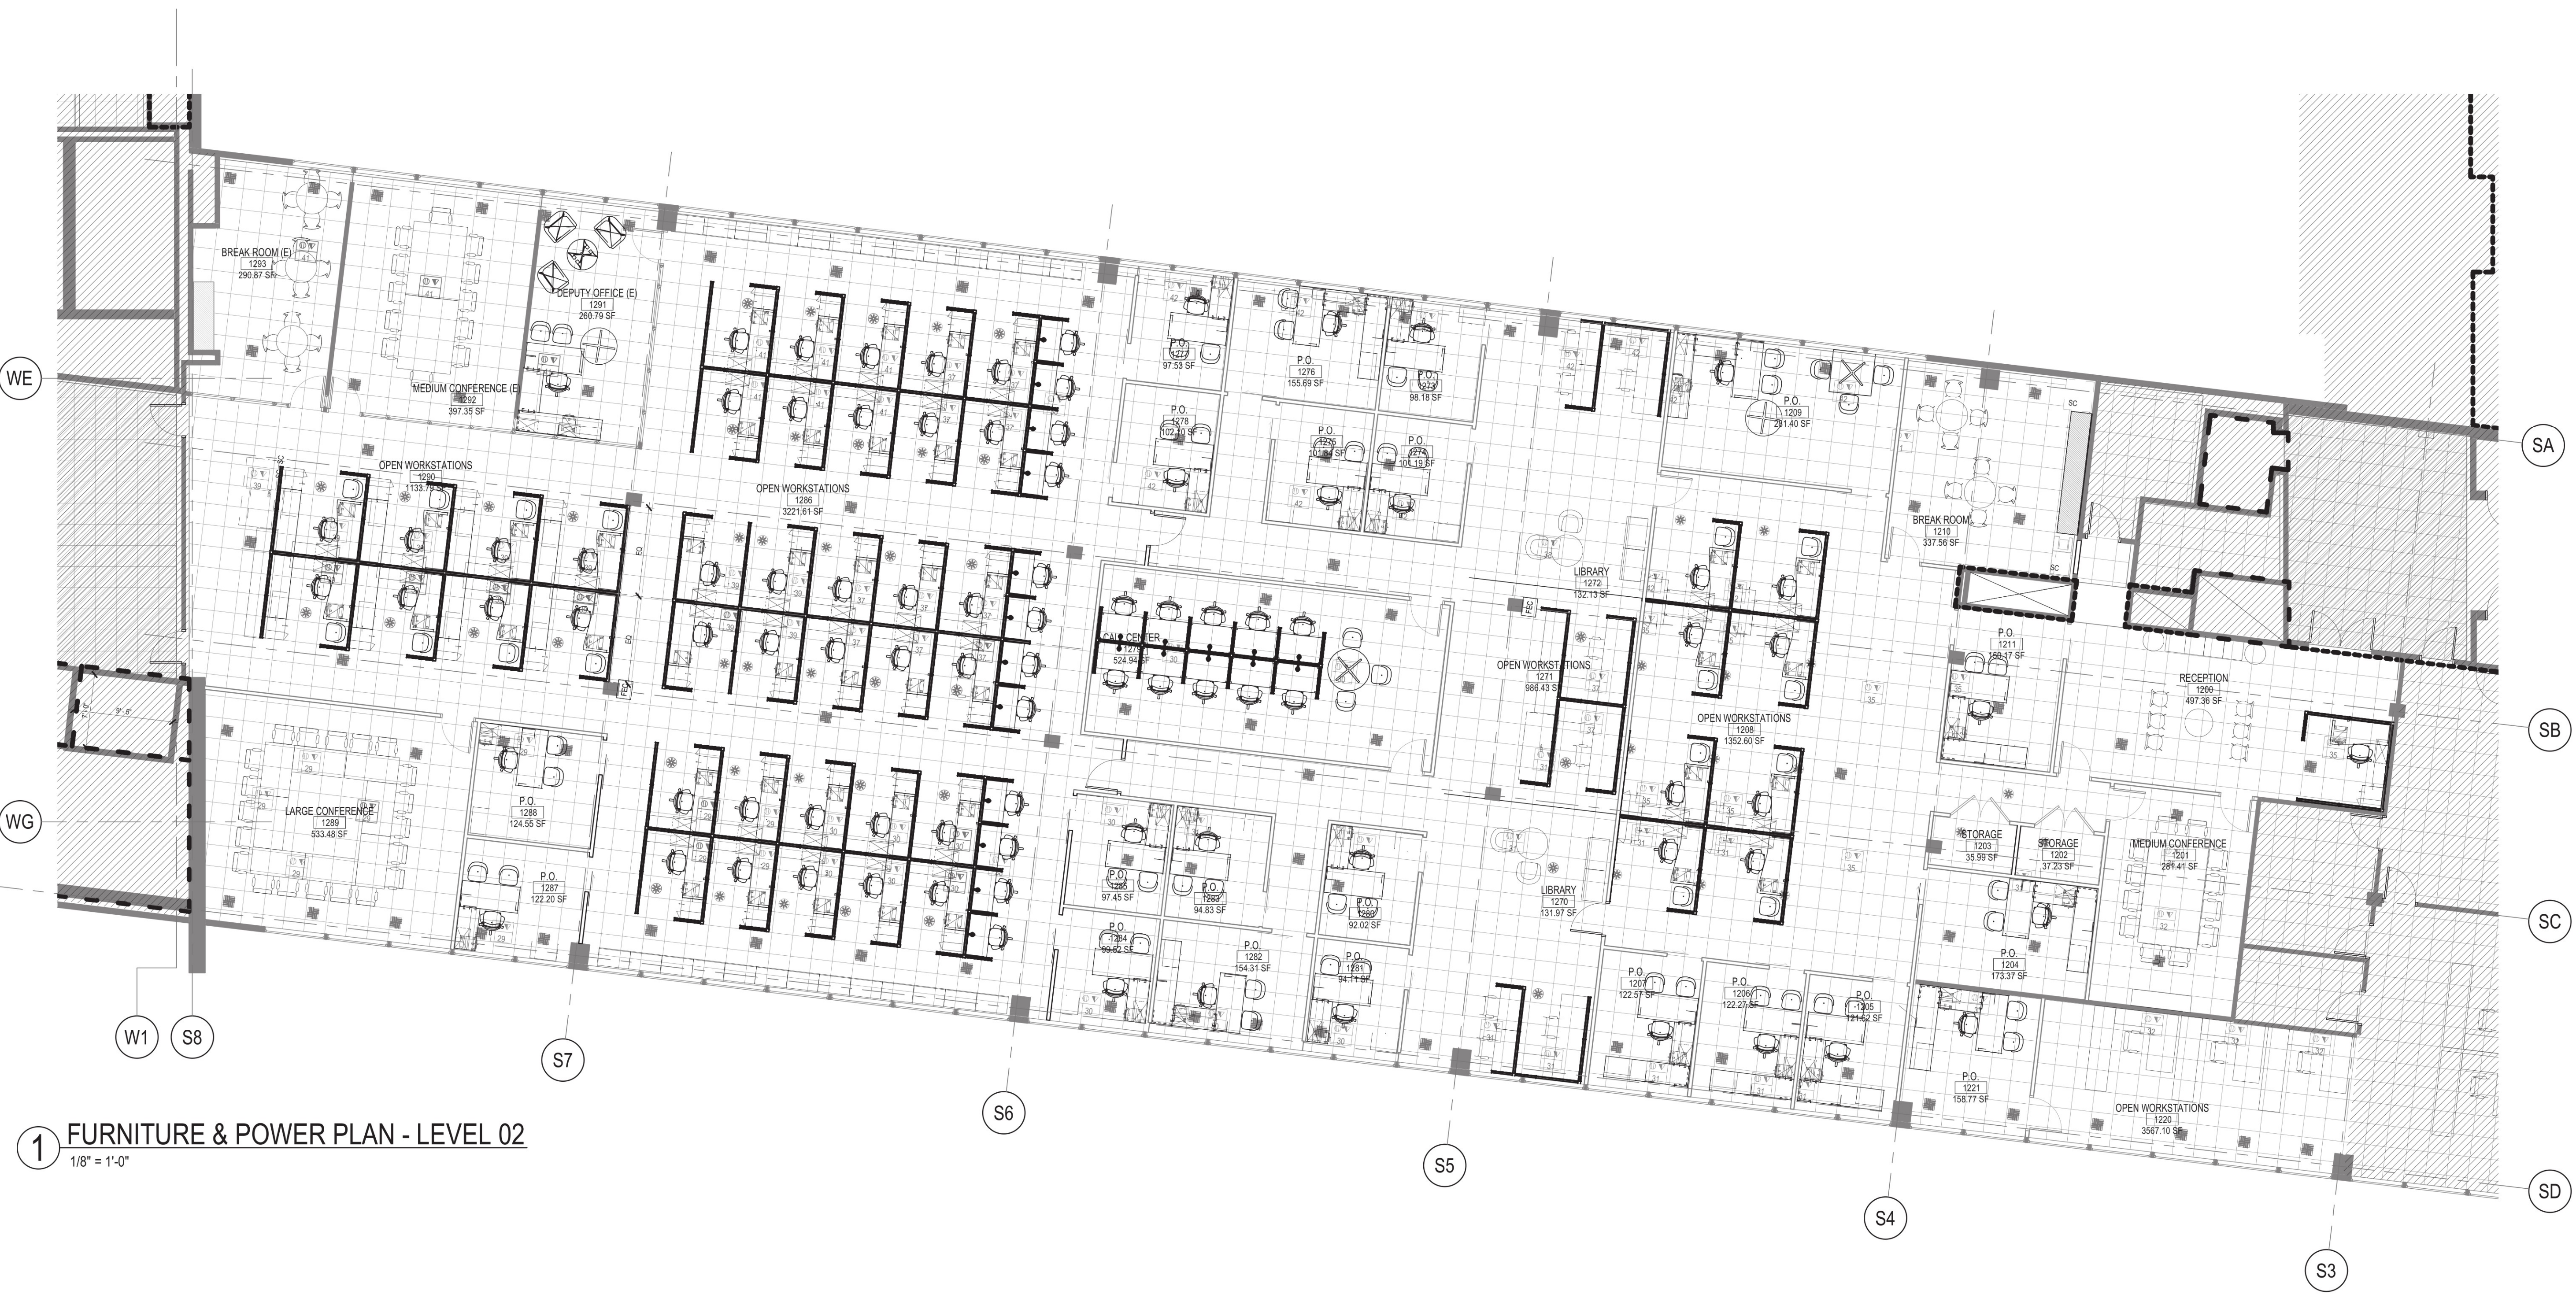

1 FURNITURE & POWER PLAN - LEVEL 02
1/8" = 1'-0"